
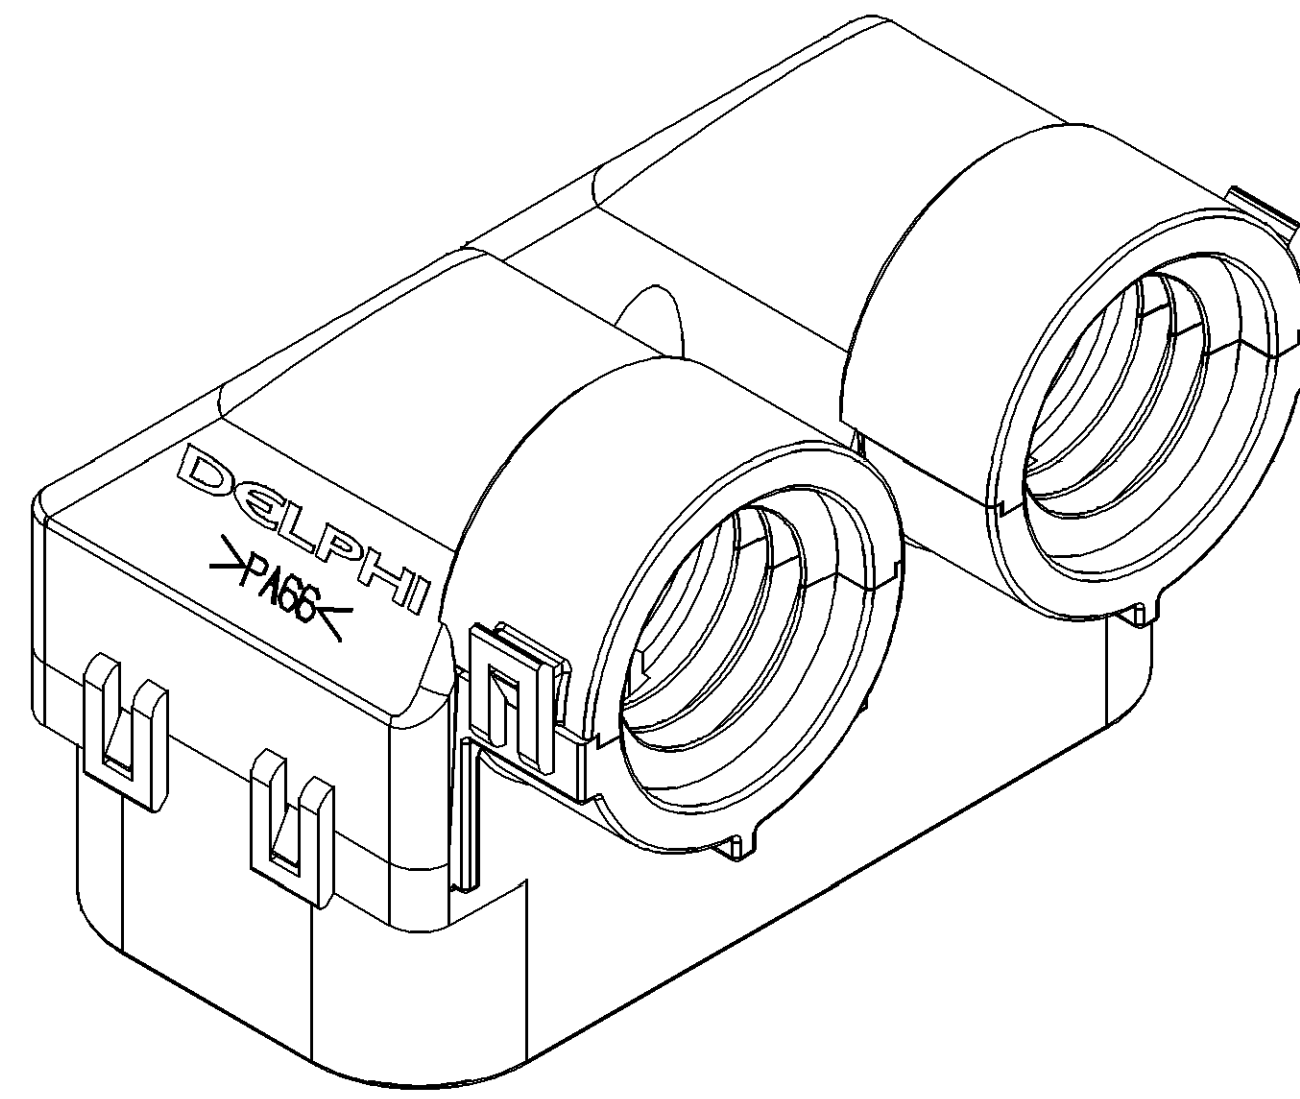
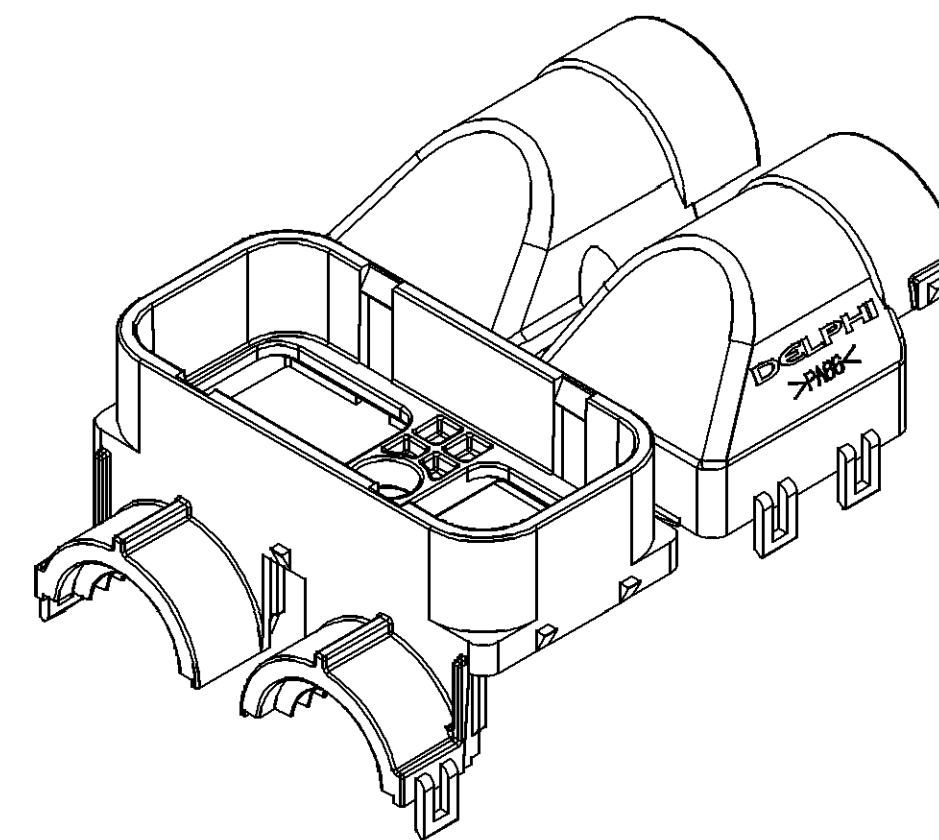
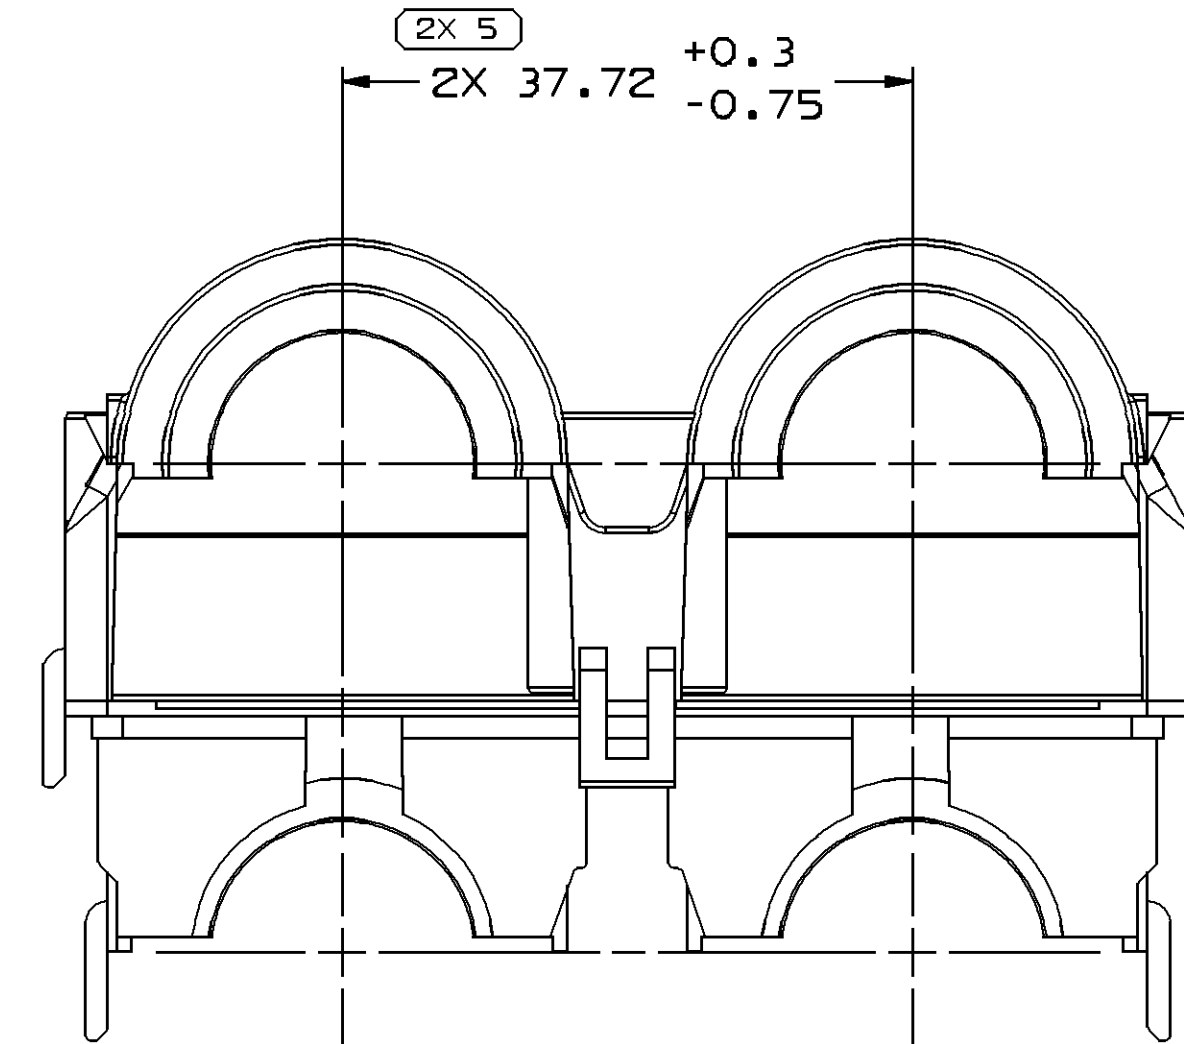


MISSING SYMBOLS		DWG STATUS					ZONE	REVISION HISTORY	AUTH	DR	APPROV 2
		DATE	STS	REV	IN/P	CHG					
NO MISSING SYMBOL NUMBER	07SE04	R	01	-	-		WAS PE123262 AND RELEASED	258635	MAC	MAC	JC
	18JA05	R	02	-	-		REVISED GRAPHICS	263364	RJM	JVM	JJC
	14FE05	R	03	-	-		DIM 2X 37.72 +0.3/-0.75 WAS 2X 37.72	264410	ECB	AUG	JC
	25FE05	R	04	-	-		REVISED WINDING GEOMETRY (2 PLC'S)	265216	AMG	AUG	JC
	06FE07	R	04	11	-		ADDED MOUNTING COMPONENT NOTE 4	452245	MLL	JUN	CN

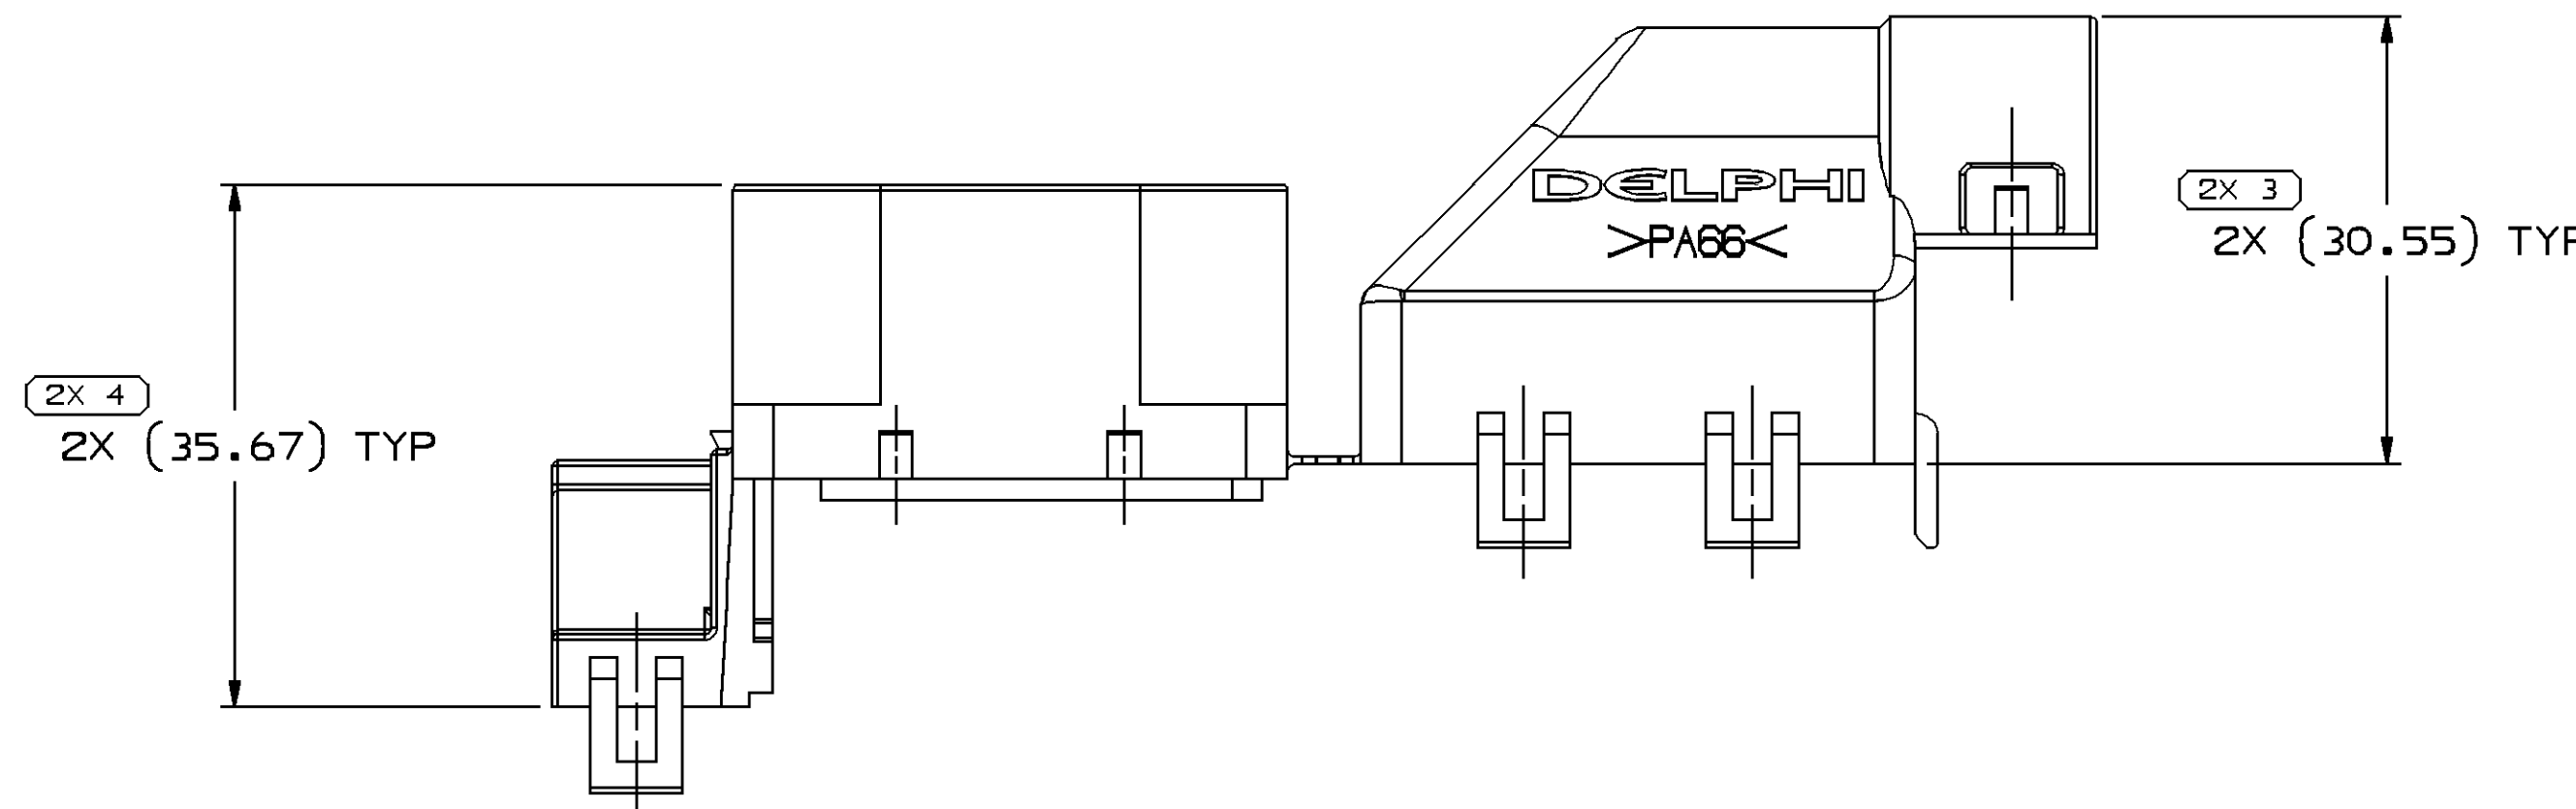

A technical drawing of a mechanical assembly. The main component is a large, rectangular block with a sloped top surface. It is labeled with the number '50'. To the left of this block is a smaller, square component. To the right is a larger, rectangular component. Below the main block are two smaller, rectangular components. The drawing shows various mechanical details, including bolts, nuts, and a flange.

[illegible]

DELPHI DELPHI PACKARD ELECTRICAL/ELECTRONIC ARCHITECTURE WARREN, OH									
							DATE		
DR									
APW/1		M. CHRESTAY					07SE04		
APW/2		M. CHRESTAY					07SE04		
APW/3		JIM CYKON					09SE04		
APW/4									
APW/5									
SUBSTANCES OF CONCERN AND RECYCLED CONTENT PER DELPHI 10949001									
MATERIAL# M3592001 PA66 HS 1M BLK									
DRAWING NAME: COV WIRE DRESS BLK									
DRAWING NUMBER 15475968									
SIZE A0	SCALE 2:1	FRAME NO 1 OF 1	SHEET NO 1 OF 1	STD R	REV A	NOV 94	AA		